


Plotted By: D:\Projects\E7829-Caribaldi\Issued\2003-04-08\E7829-3.dwg 4-23-03 11:51:08 AM Gary Jang

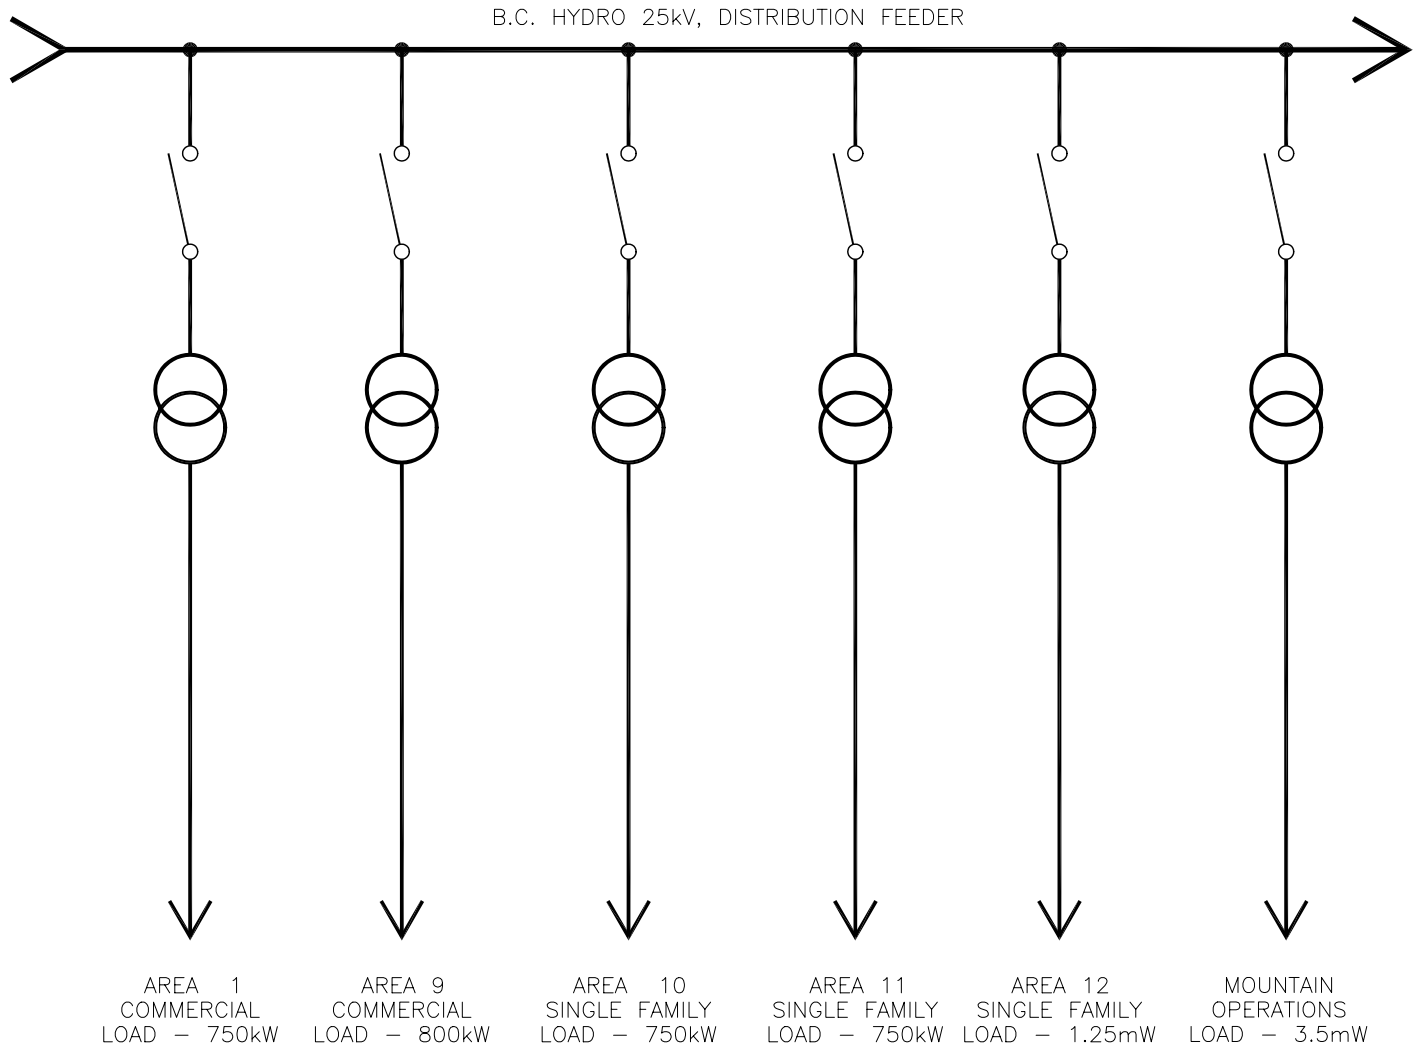

NOTES

1. DRAWING REPRESENTS TOTAL LOAD FOR EACH AREA AT BUILD OUT. IT IS NOT INTENDED THAT THIS WILL OCCUR BY THE END OF PHASE 1.
2. SINGLE FAMILY/COMMERCIAL REFERS TO THE DEVELOPMENT TYPE IN THAT AREA.
3. LOADS ARE BASED ON B.C. HYDRO LOAD DEMANDS FOR TYPICAL OCCUPANCY.

PHASE ONE DISTRIBUTION

No.	Revision	Date
F		
E		
D		
C		
B		
A		

SECTION 2	
SINGLE LINE DIAGRAM	
SHAFLIK ENGINEERING	DRAWING No. E-7829-03-3 OF 4